


- LEGEND**
- BACKFLOW PREVENTER
 - BOLLARD
 - ⊗ ELECTRIC VAULT
 - ELEVATION
 - ⊕ FIRE HYDRANT
 - ⊕ GRATE INLET
 - ⊕ GREASE TRAP
 - LIGHT POLE
 - ⊕ MITERED END SECTION
 - POWER POLE
 - SANITARY SEWER MANHOLE
 - SEWER CLEAN OUT
 - SIGN
 - TELEPHONE PEDESTAL
 - WATER METER
 - WATER VALVE
 - WELL
 - GUY WIRE
 - U.G. SANITARY SEWER LINE
 - U.G. STORM SEWER LINE
 - CHERRY LAUREL
 - OAK
 - PALM
 - PINE

GENERAL NOTES:

1. ALL PROPOSED PAVEMENT RADII TO BE 3' UNLESS OTHERWISE NOTED.
2. ALL STOP SIGNS SHALL REMAIN FROM FROM VISUAL OBSTRUCTIONS.

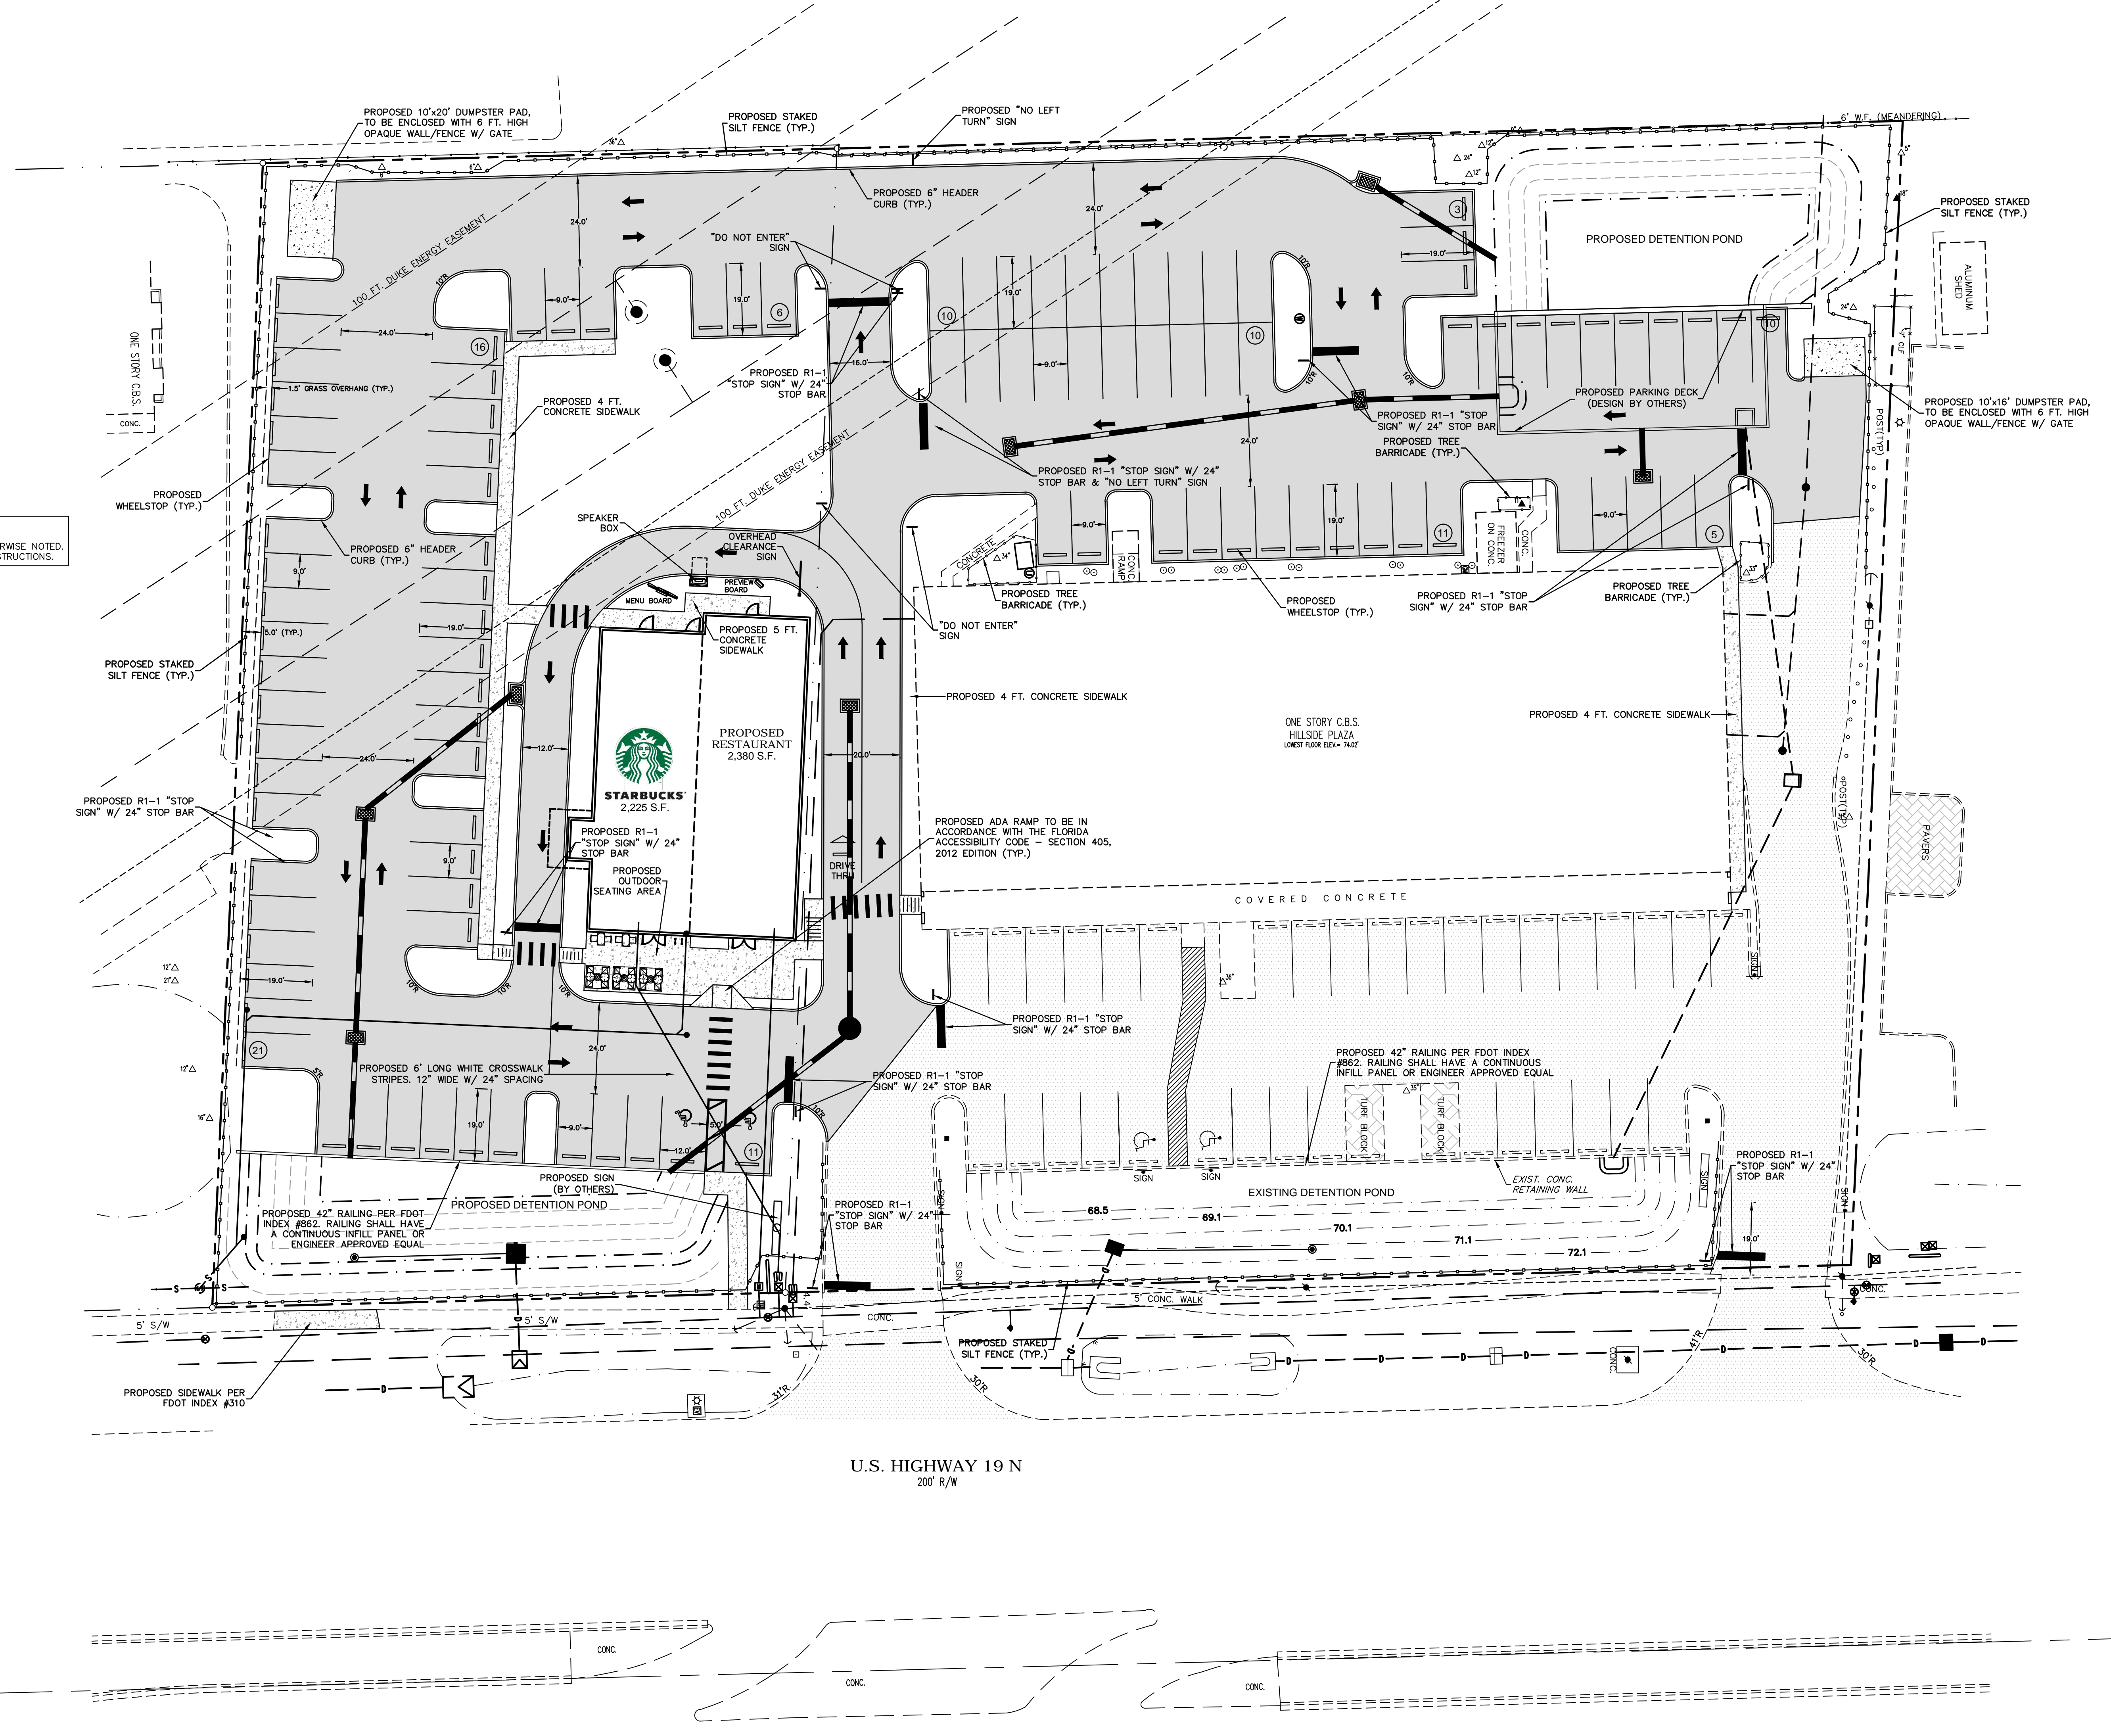

10-23-2015 REVISED PER FOOT COMMENTS	11-13-2015 REVISED PER PHILLIPS COUNTY & DUKE ENERGY COMMENTS
Scale: 1"=20'	Date: 06-02-2015
Design: RFA	Drawn: RFA
Checked: JCL	Job No.: 704-01
Toll Free: 1-800-282-7960	Web: WWW.LMAENGR.COM

STARBUCKS/HILLSIDE PLAZA
 SITE PLAN

HLMD PARTNERS, LLC
 7085 MANIUS CENTER ROAD
 EAST SYRACUSE, NY 13057

LMA
 Landon, Moree & Associates, Inc.
 Civil & Environmental Engineers - Planners - Surveyors

31622 U.S. 10 NORTH PALM HARBOR, FLORIDA 34484
 Toll Free: 1-800-282-7960, WWW.LMAENGR.COM